


Fan Coil Unit (matching colours linked)

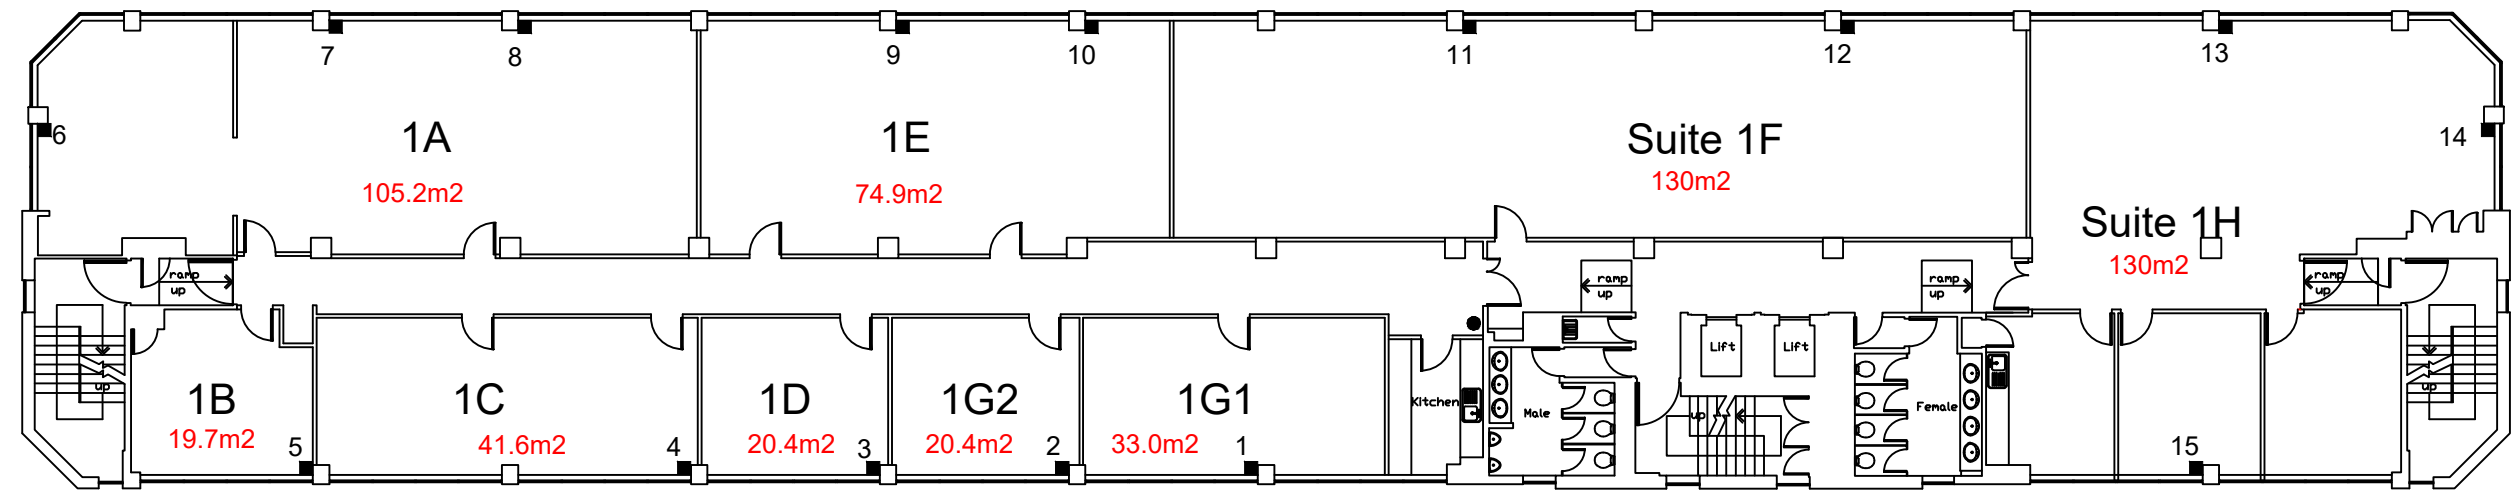

- Phone DP
- Phone DB

FIRST FLOOR PLAN

WESTMEAD HOUSE
FARNBOROUGH
HAMPSHIRE
GU14 7LP
Approx Scale 1:200@A3